
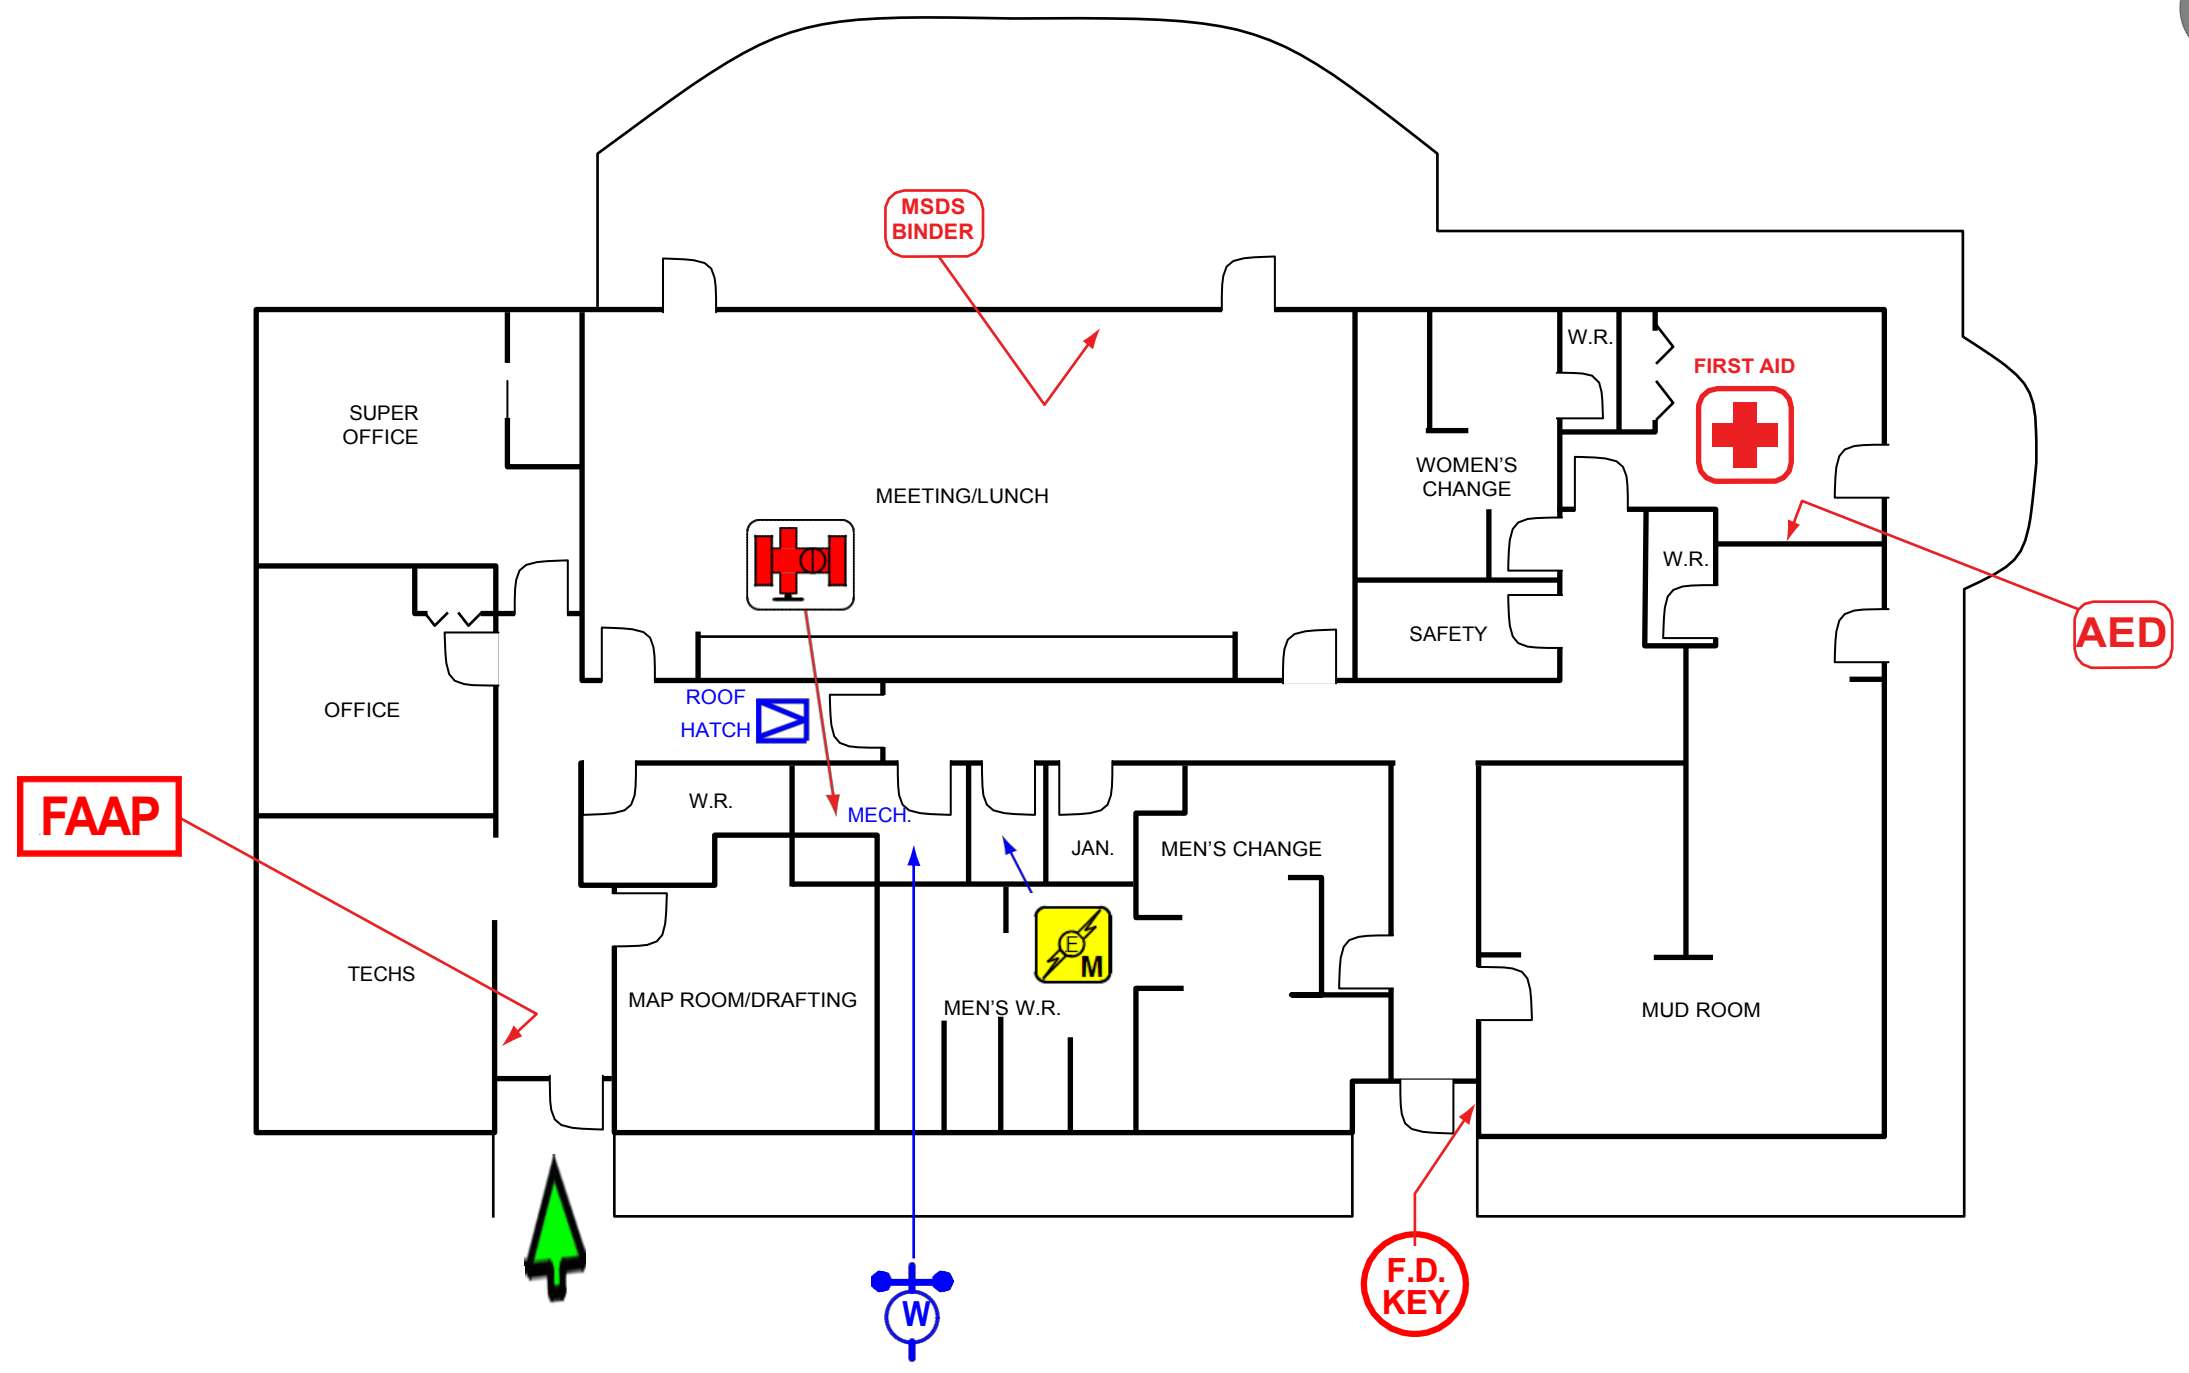


LEGEND	
	FIRE DEPARTMENT CONNECTION
	HYDRANT PRIVATE
	GAS SHUT-OFF
	FIRE ALARM ANNUNCIATOR
	FIRE DEPARTMENT KEY
	ASSEMBLY AREA

Name of Company producing FSP/PIP

Building Name (Arial Bold 14)
 Drawing Name
 Street Address
Site Plan
Pre-Incident Plan

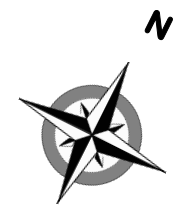

LEGEND	
	FIRE ALARM ANNUNCIATOR
	SPRINKLER VALVES
	MAIN ELECTRICAL ROOM
	WATER SHUT-OFF
	FIRE DEPARTMENT KEY

Name of Company producing FSP/PIP

Building Name (Arial Bold 14)
 Drawing Name
 Street Address
 Floor Plan
 Pre-Incident Plan